



- Zone 1
- Zone 2
- Zone 3
- Zone 4
- Zone 5
- Zone 6
- Zone 7
- Zone 8
- Zone 9
- Zone 10
- Approximate location of smoke vent
- Existing beam detection (nb at one level only)


1 Ground Floor Plan  
Scale: 1:100

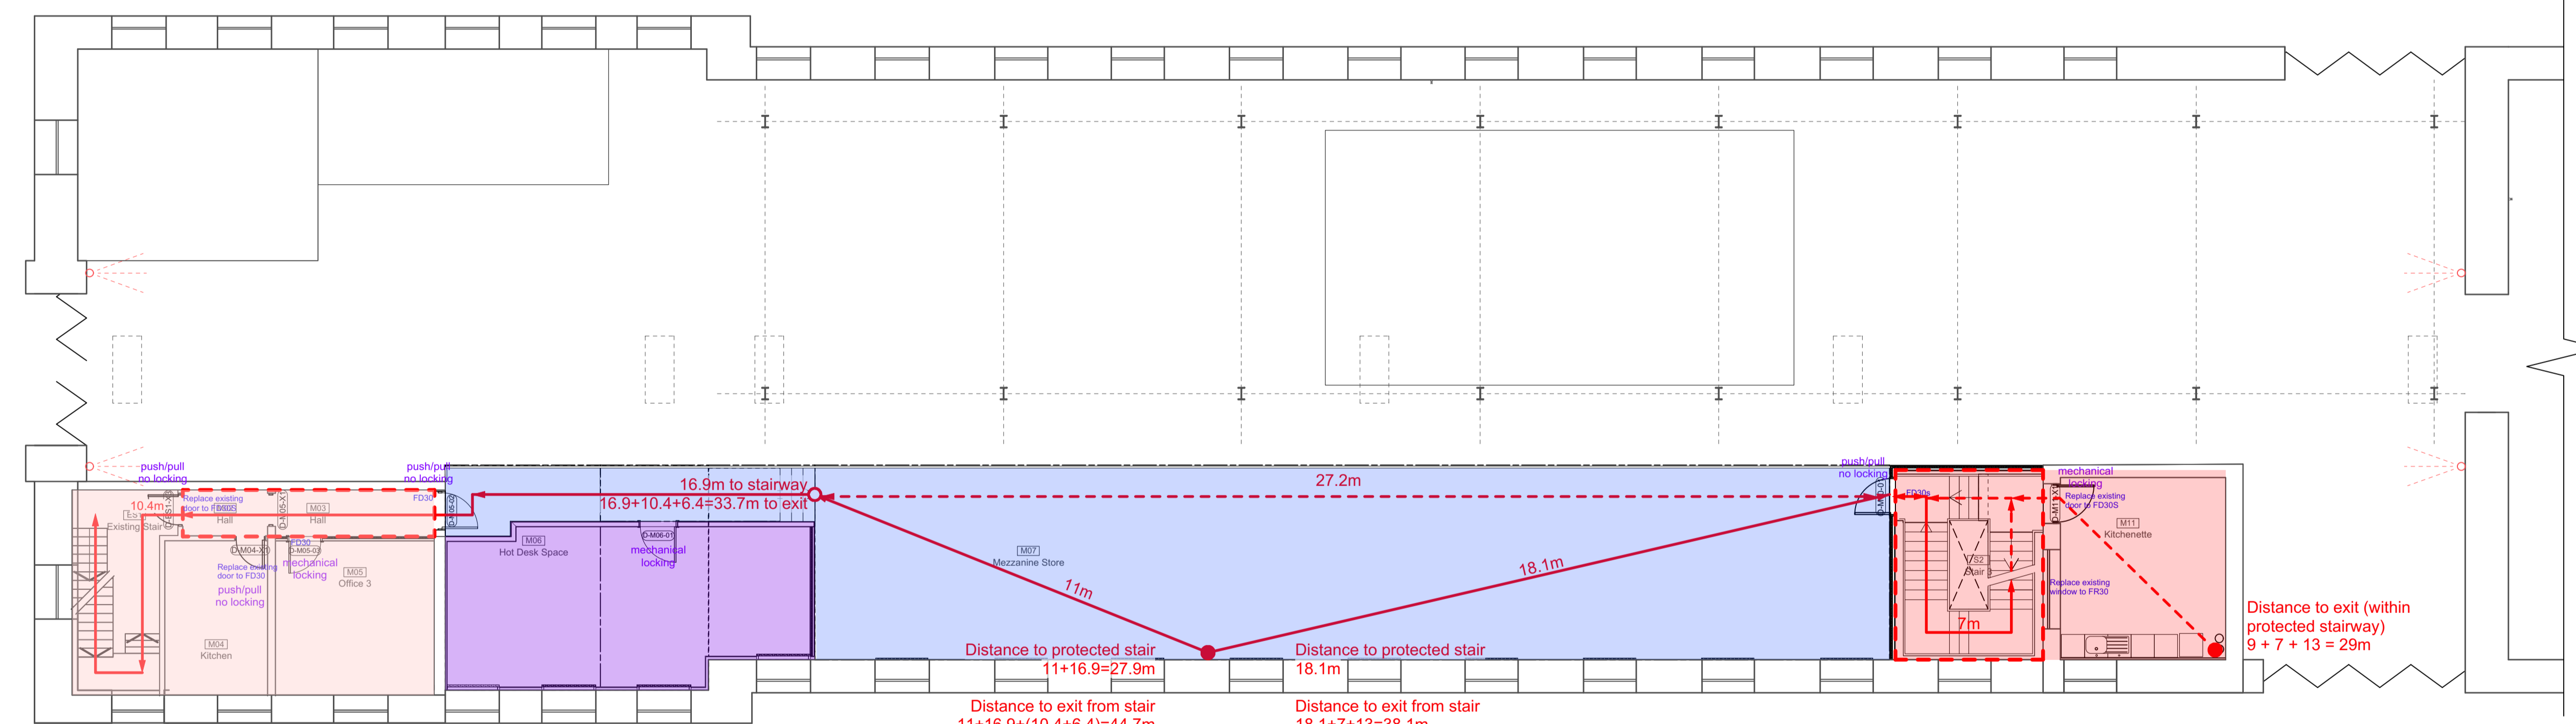

2 Mezzanine / First Floor  
Scale: 1:100

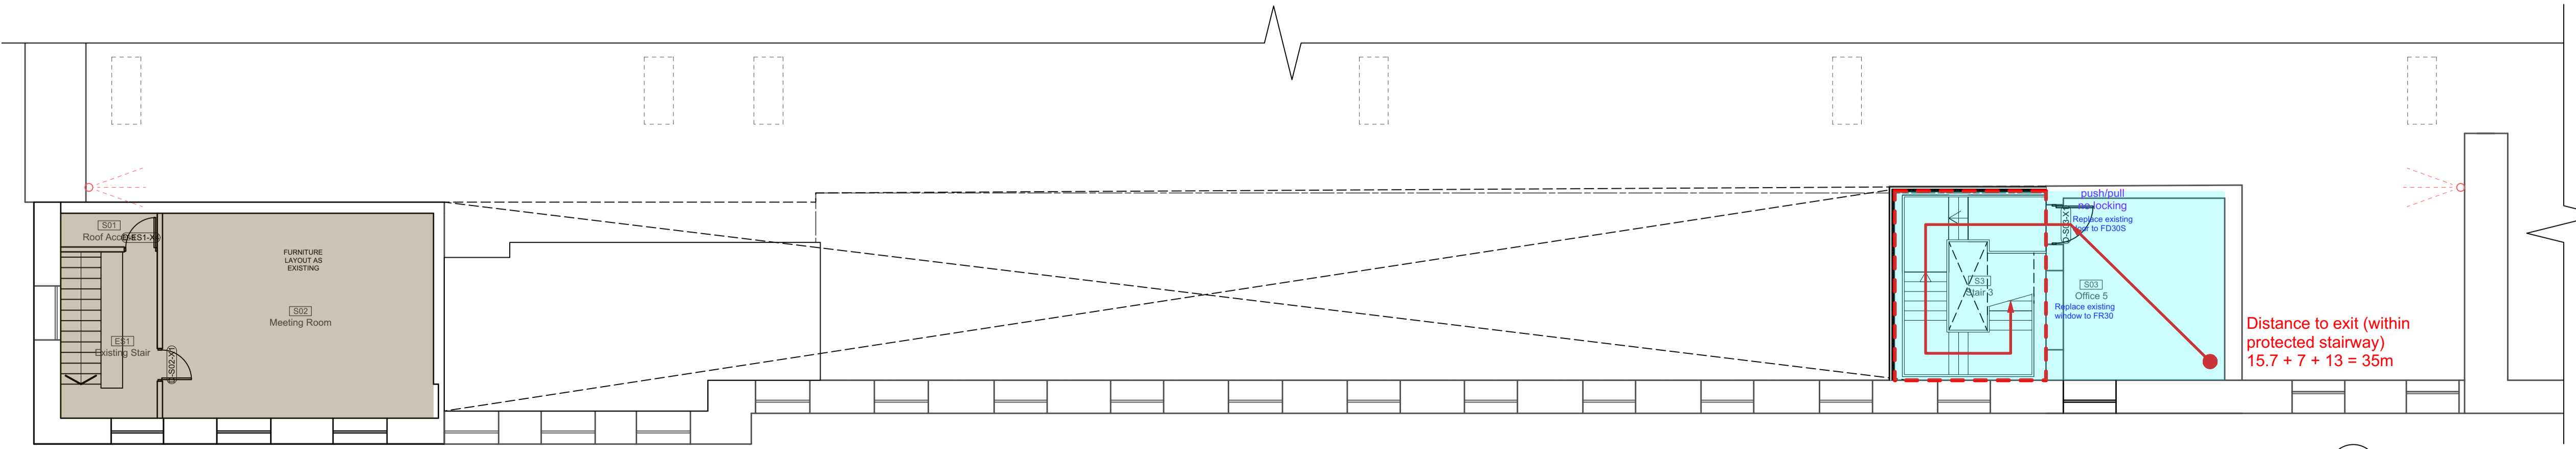

3 Second Floor  
Scale: 1:100

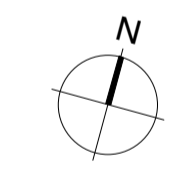

No.	Date	By	Comments
PO3	01.04.2021	ST	Incorporated client comments
PO2	18.03.2021	ST	Reduced scope issue
PO1	02.11.2020	ST	Issued for Tender
-	25.08.2020	ST	Issued for Discussion

**PRELIMINARY**  
Drawing Status

**NATIONAL MUSEUM OF THE ROYAL NAVY  
HISTORIC SHIPS WORKSHOP**  
**Dannatt, Johnson Architects**  
Unit 1 The Wireworks, 77 Great Suffolk Street, London SE1 0BU  
Telephone (020) 7357 7100 Fax (020) 7357 7200

Drawing Title  
**Proposed Bay 1 Fire Plans**

Drawing Number  
**605b-FD-19-000**

Drawn	Checked	Scale	Date	Revision
ST	DJ	1:100@A1	Aug 2020	PO3