



1 Ground Floor Plan  
Scale: 1:100

- Initial site area for strip out of WCs
- Mezzanine installation areas. Early in site phase
- Site areas following mezzanine installation
- 1st floor alterations. Last 4 weeks of contract period
- Shared access circulation and escape
- Site cabins and storage
- Possible Hera Fencing line

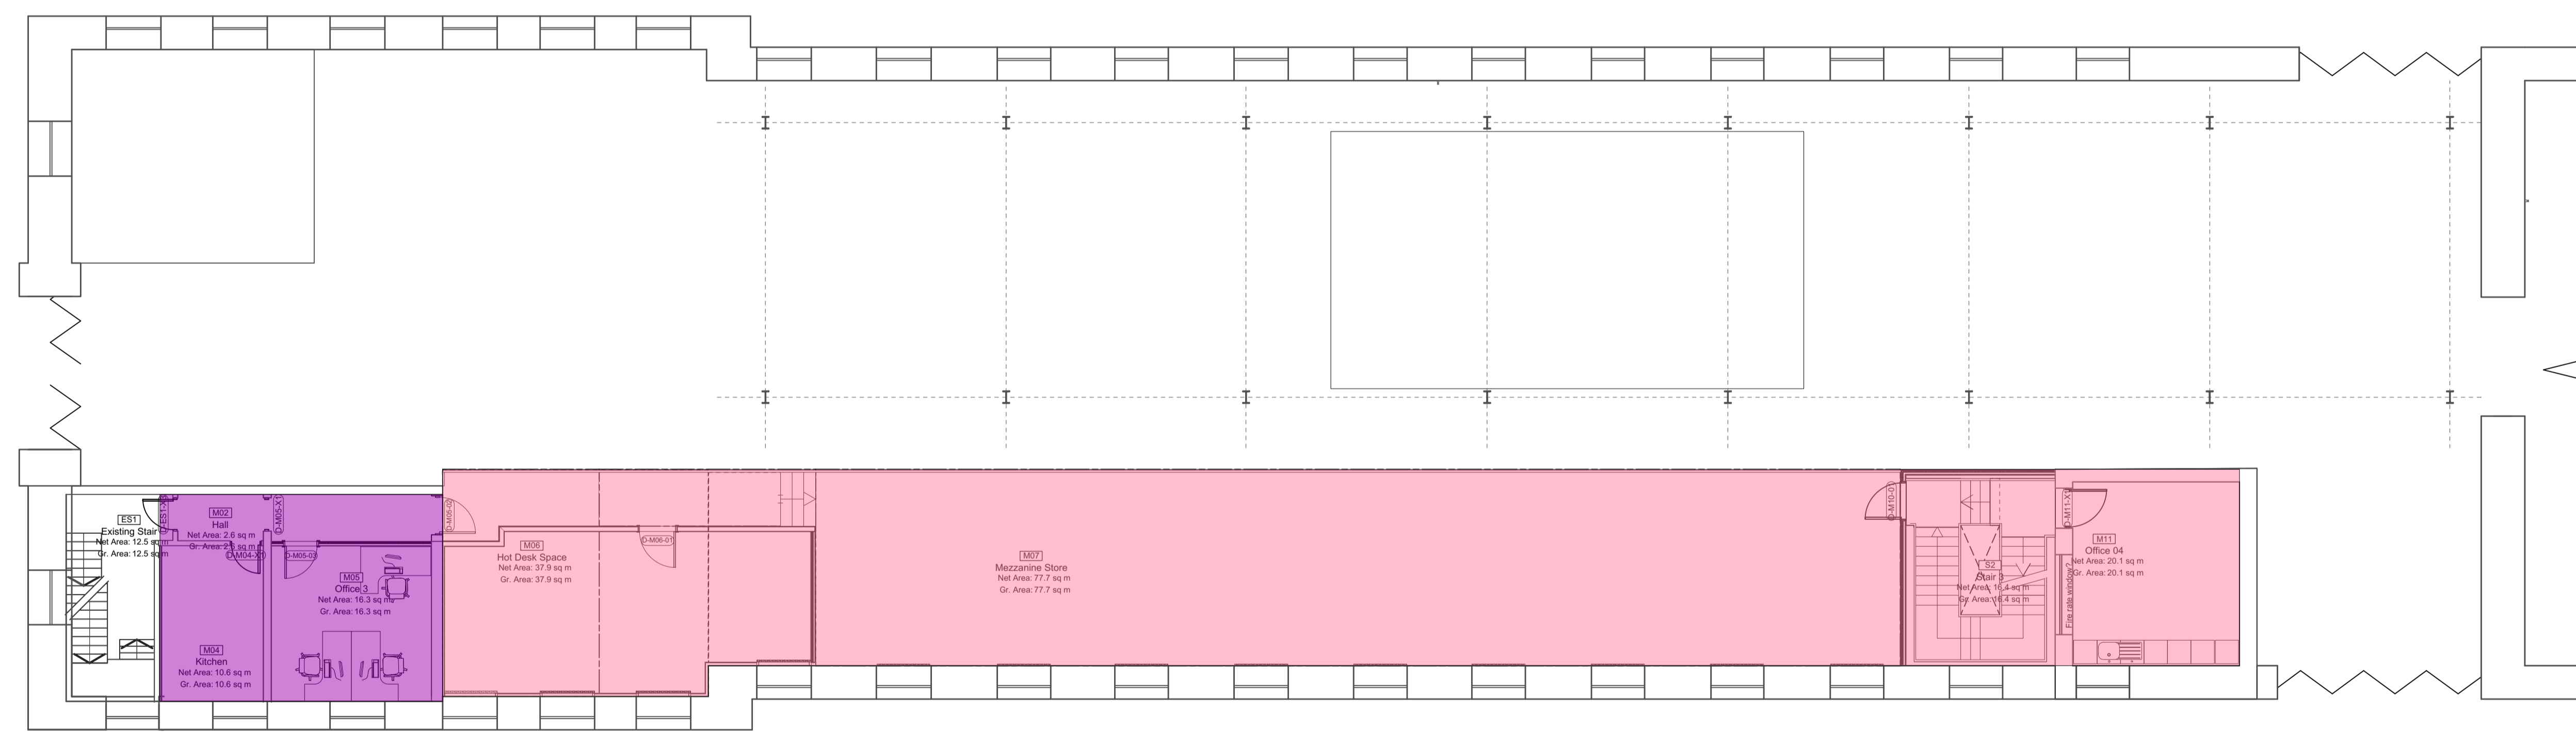

2 Mezzanine / First Floor  
Scale: 1:100

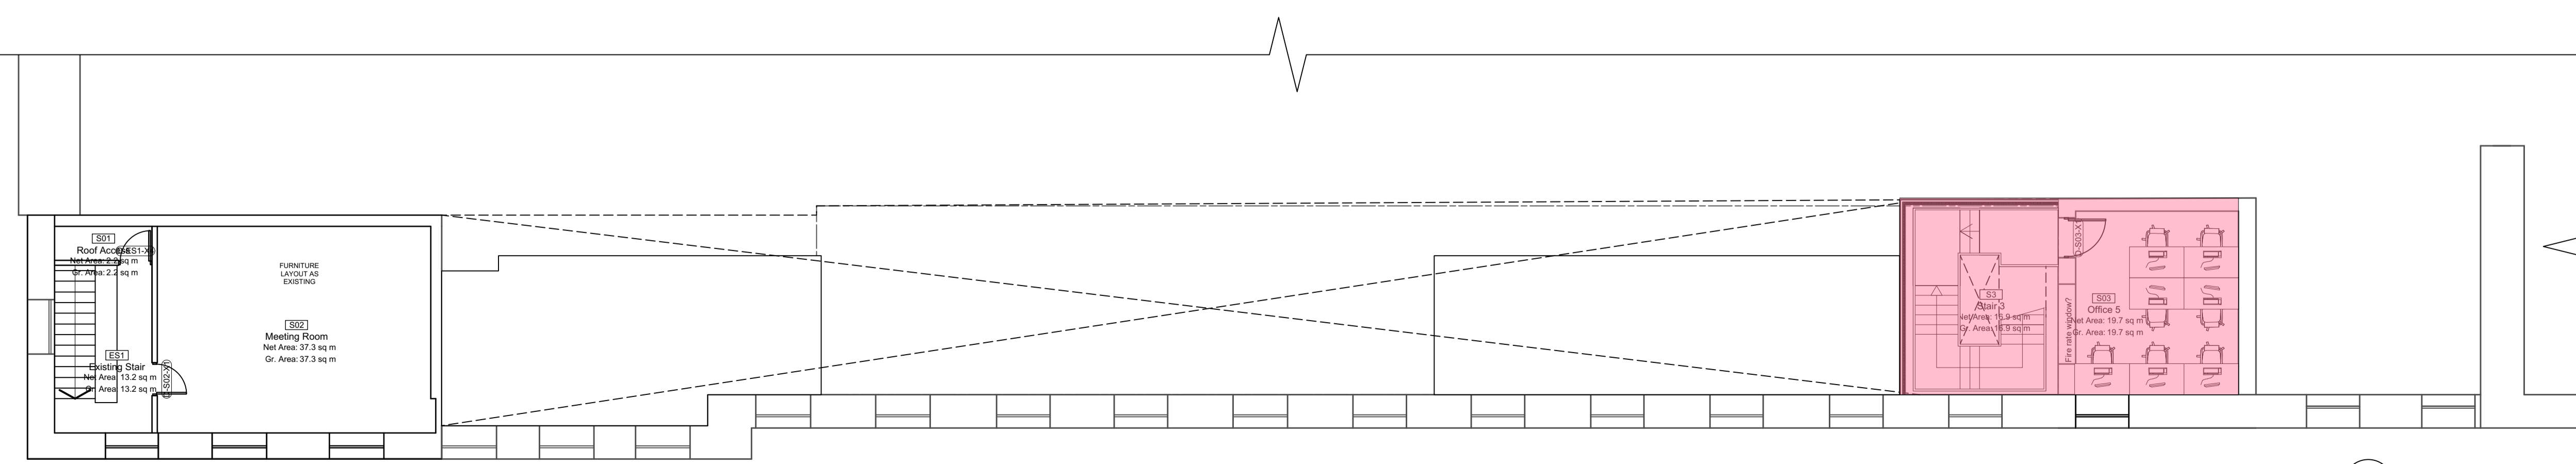

3 Second Floor  
Scale: 1:100

P02	20.40.2021	ST	Scope Reduction
P01	02.11.2020	ST	Issued for Tender
No.	Date	By	Comments
Revisions			

**TENDER**  
Drawing Status

**NATIONAL MUSEUM OF THE ROYAL NAVY  
HISTORIC SHIPS WORKSHOP**  
**Dannatt, Johnson Architects**  
Unit 1 The Wireworks, 77 Great Suffolk Street, London SE1 0BU  
Telephone (020) 7357 7100 Fax (020) 7357 7200

Drawing Title  
**Proposed Bay 1 Access and Logistics Plans**

Drawing Number  
**605b-SKD-00-100**

Drawn	Checked	Scale	Date	Revision
ST	DJ	1:100@A1	Oct 2020	P02