




1 Ground Floor Plan
Scale: 1:100

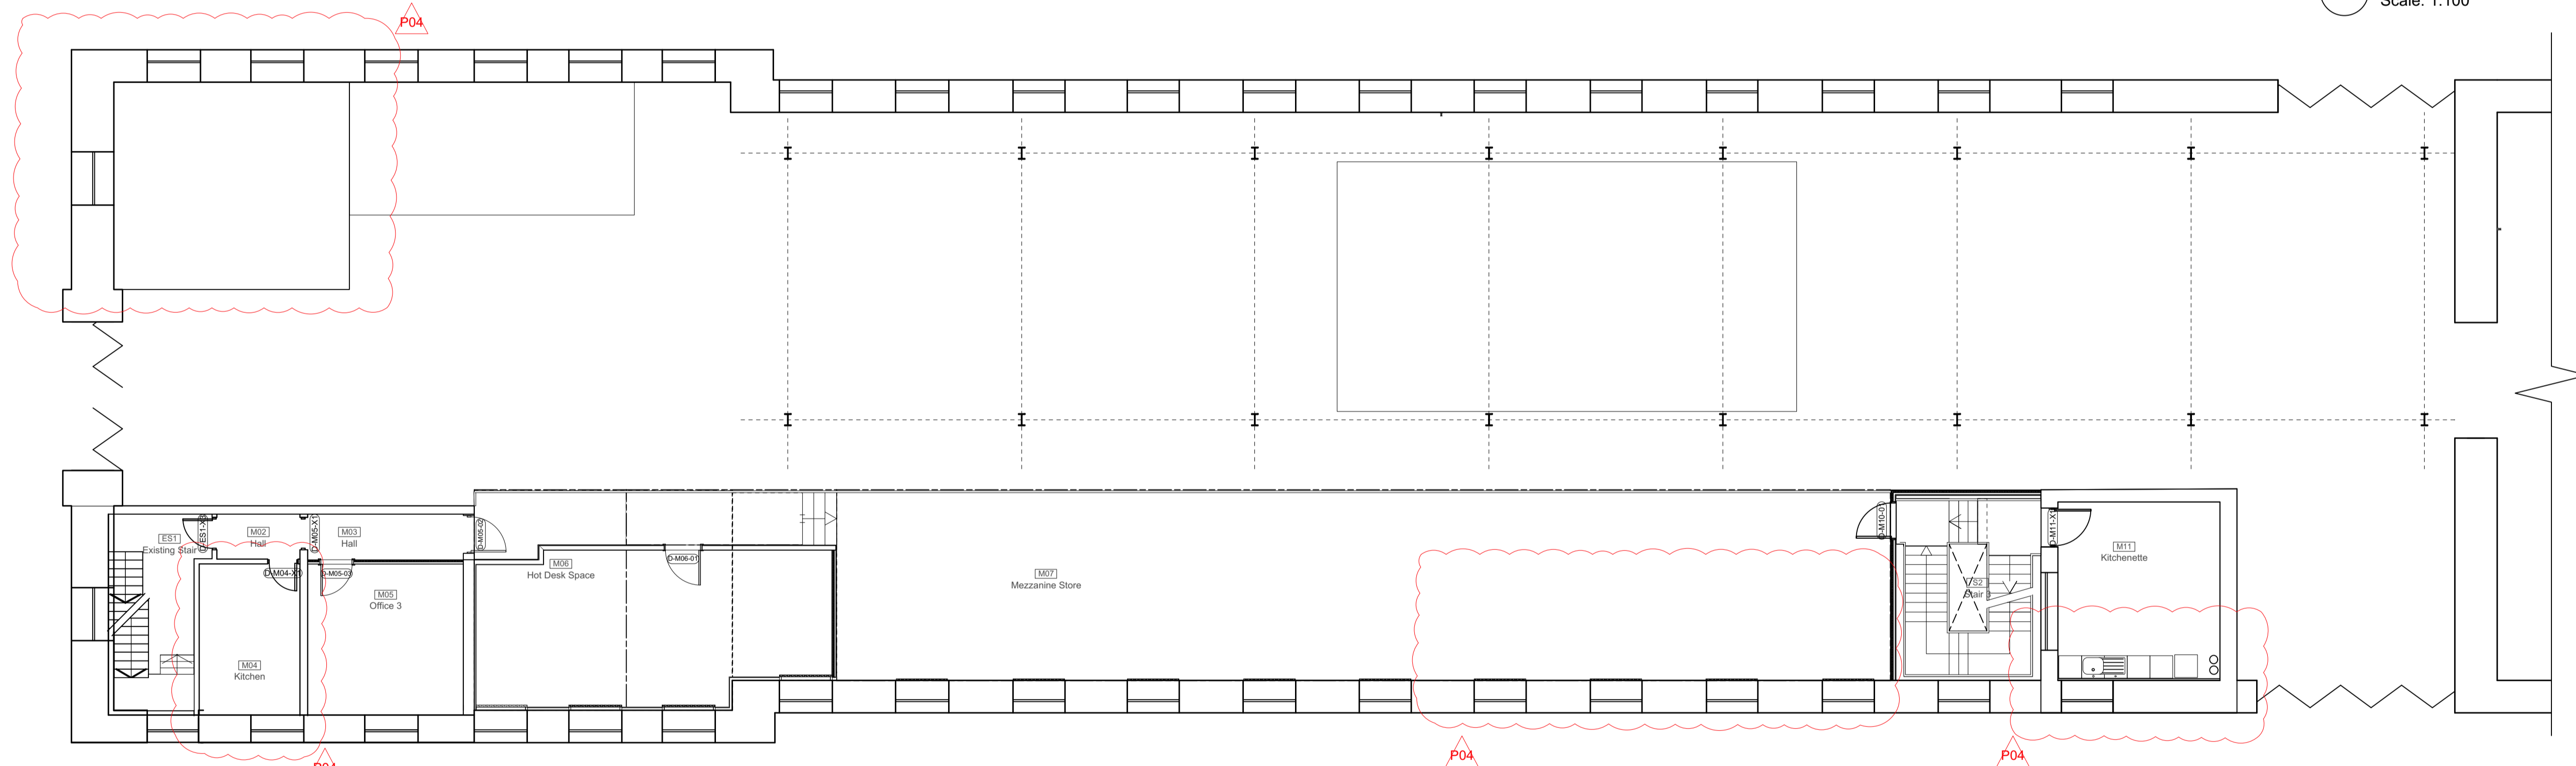

2 Mezzanine / First Floor
Scale: 1:100

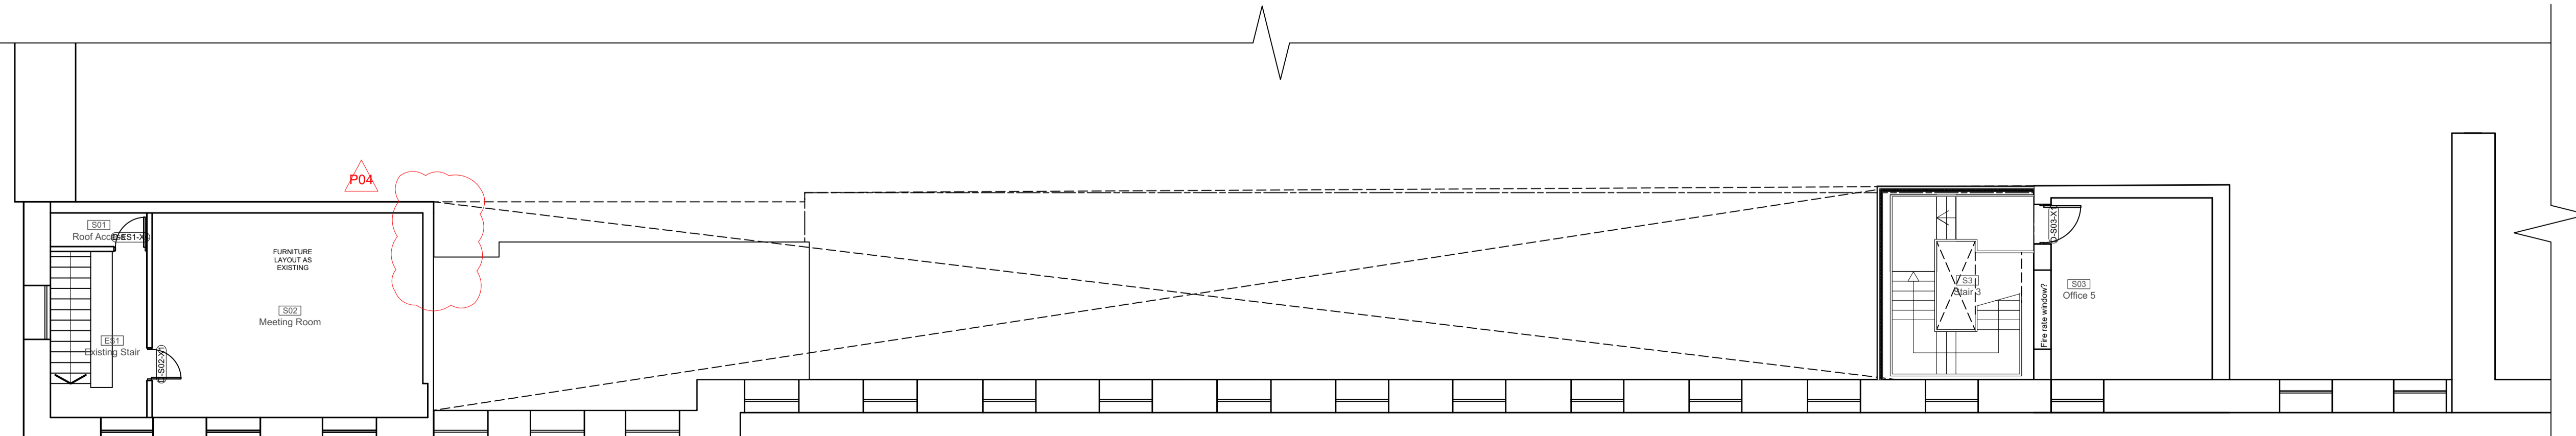

3 Second Floor
Scale: 1:100

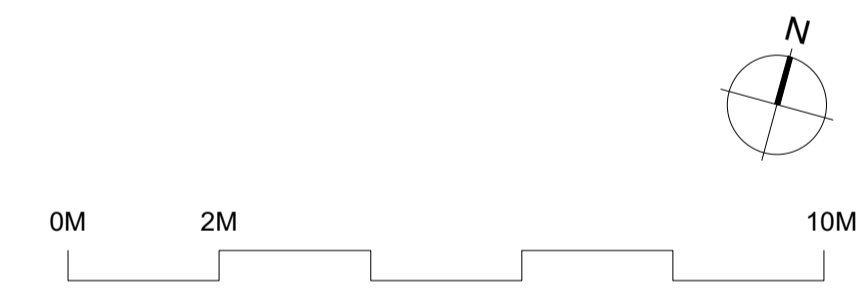

P04	20.04.2021	ST	Scope Reduction - issued for tender
P03	20.01.2021	ST	Scope reduction sign off
P02	02.11.2020	ST	Reissued for Tender
P01	02.11.2020	ST	Issued for Planning
-	25.08.2020	ST	Issued for Discussion
No.	Date	By	Comments
Revisions			

TENDER
Drawing Status

**NATIONAL MUSEUM OF THE ROYAL NAVY
HISTORIC SHIPS WORKSHOP**
Dannatt, Johnson Architects
Unit 1 The Wireworks, 77 Great Suffolk Street, London SE1 0BU
Telephone (020) 7357 7100 Fax (020) 7357 7200

Drawing Title
Proposed Bay 1 Overview

Drawing Number
605b-WD-10-000

Drawn	Checked	Scale	Date	Revision
ST	DJ	1:100@A1	Aug 2020	P04