



1 Ground Floor Plan  
Scale: 1:100

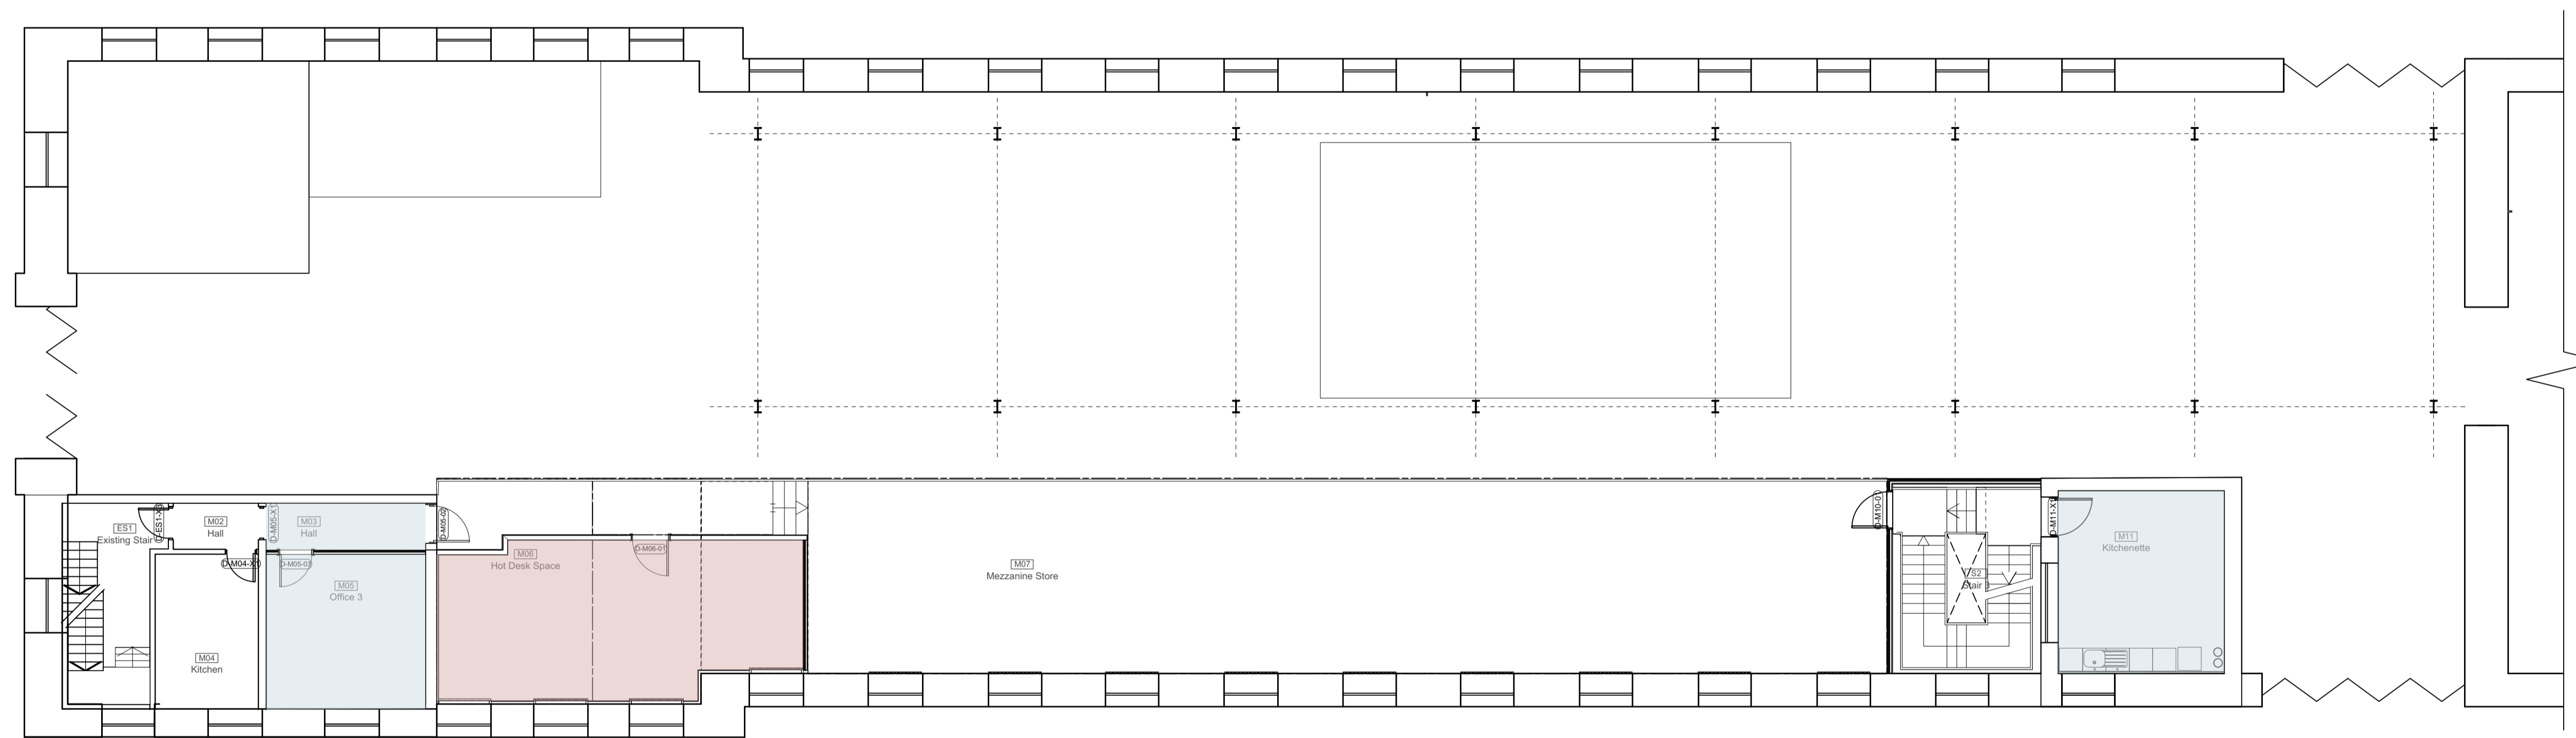


2 Mezzanine / First Floor  
Scale: 1:100

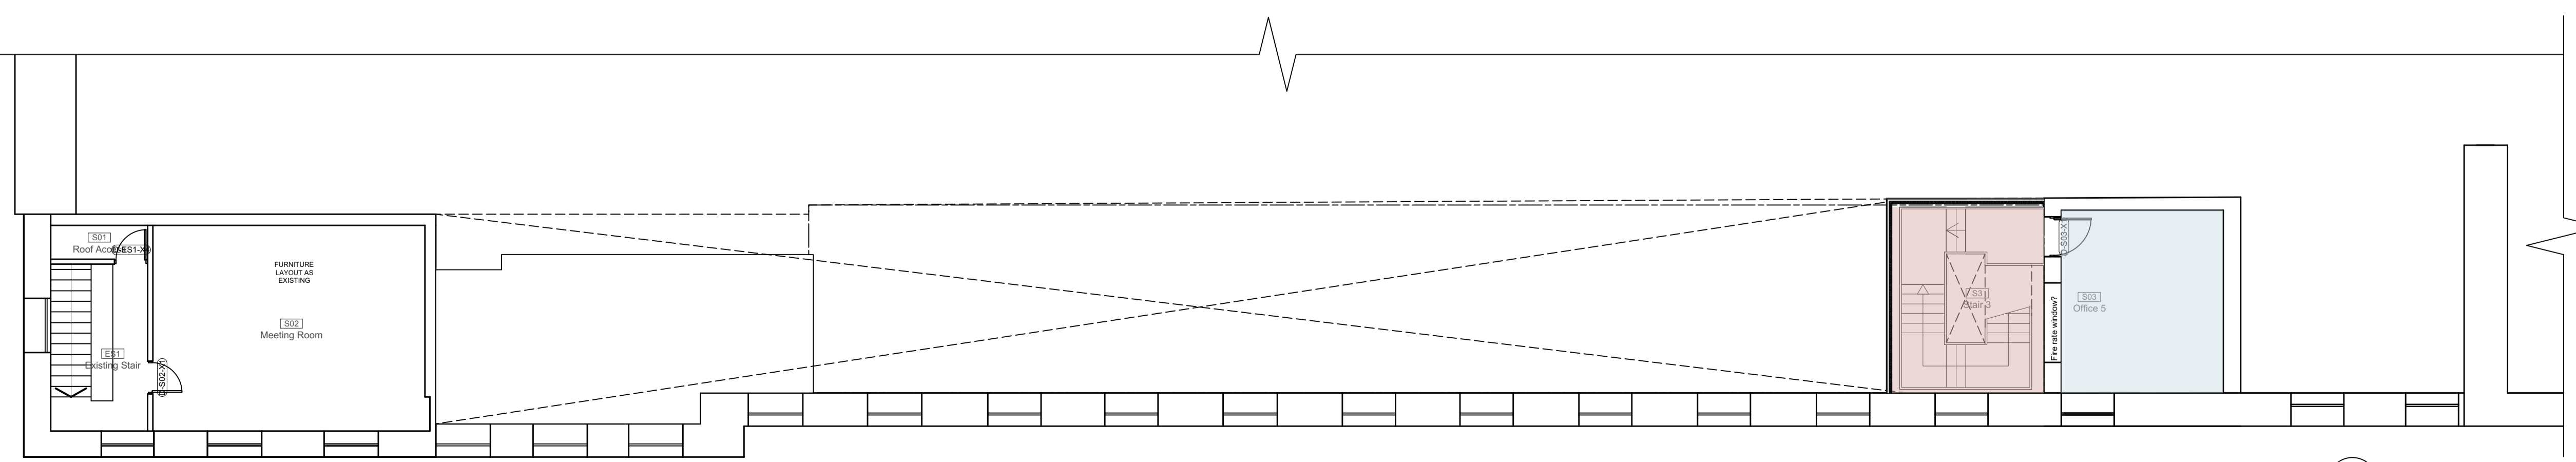

3 Second Floor  
Scale: 1:100

**CEILING FINISH**

- Decorate new ceiling
- Decorate existing ceiling

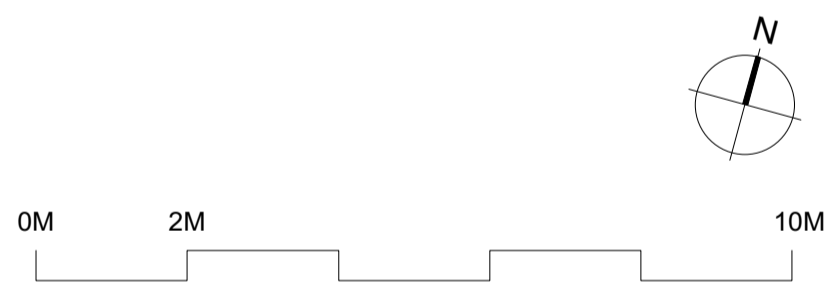

P02/20.04.2021	ST	Scope Reduction-issued for tender	
P01/02.11.2020	ST	Issued for Tender	
No.	Date	By	Comments
Revisions			

**TENDER**  
Drawing Status

**NATIONAL MUSEUM OF THE ROYAL NAVY  
HISTORIC SHIPS WORKSHOP**  
**Dannatt, Johnson Architects**  
Unit 1 The Wireworks, 77 Great Suffolk Street, London SE1 0BU  
Telephone (020) 7357 7100 Fax (020) 7357 7200

Drawing Title  
**Proposed Bay 1 - Ceiling Finishes**

Drawing Number  
**605b-WD-13-003**

Drawn	Checked	Scale	Date	Revision
ST	DJ	1:100@A1	Aug 2020	P02