




1 Elevation  
Scale: 1:10

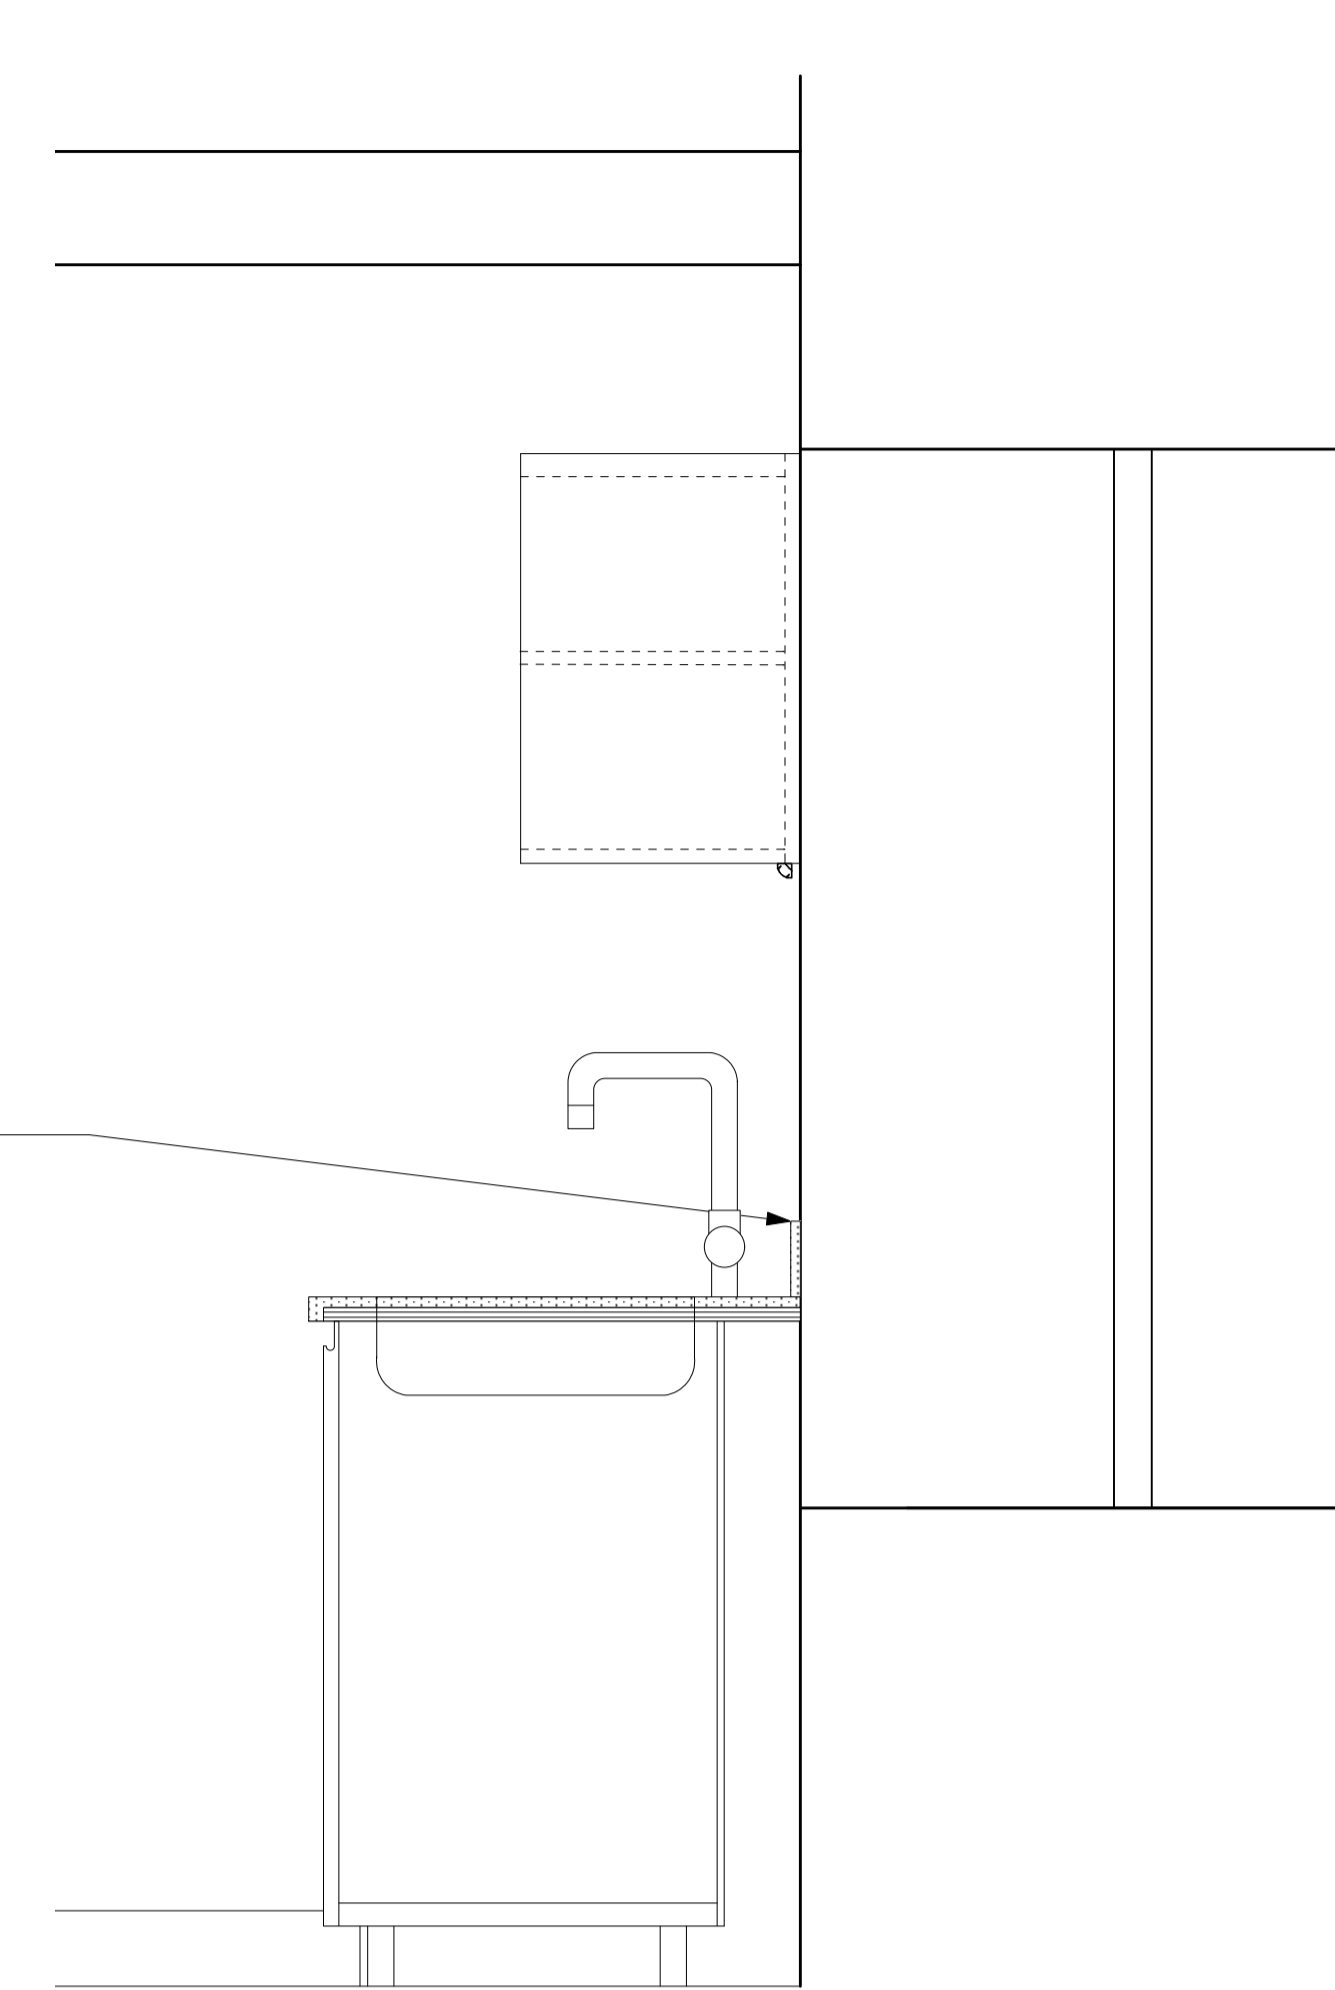

2 Section  
Scale: 1:10

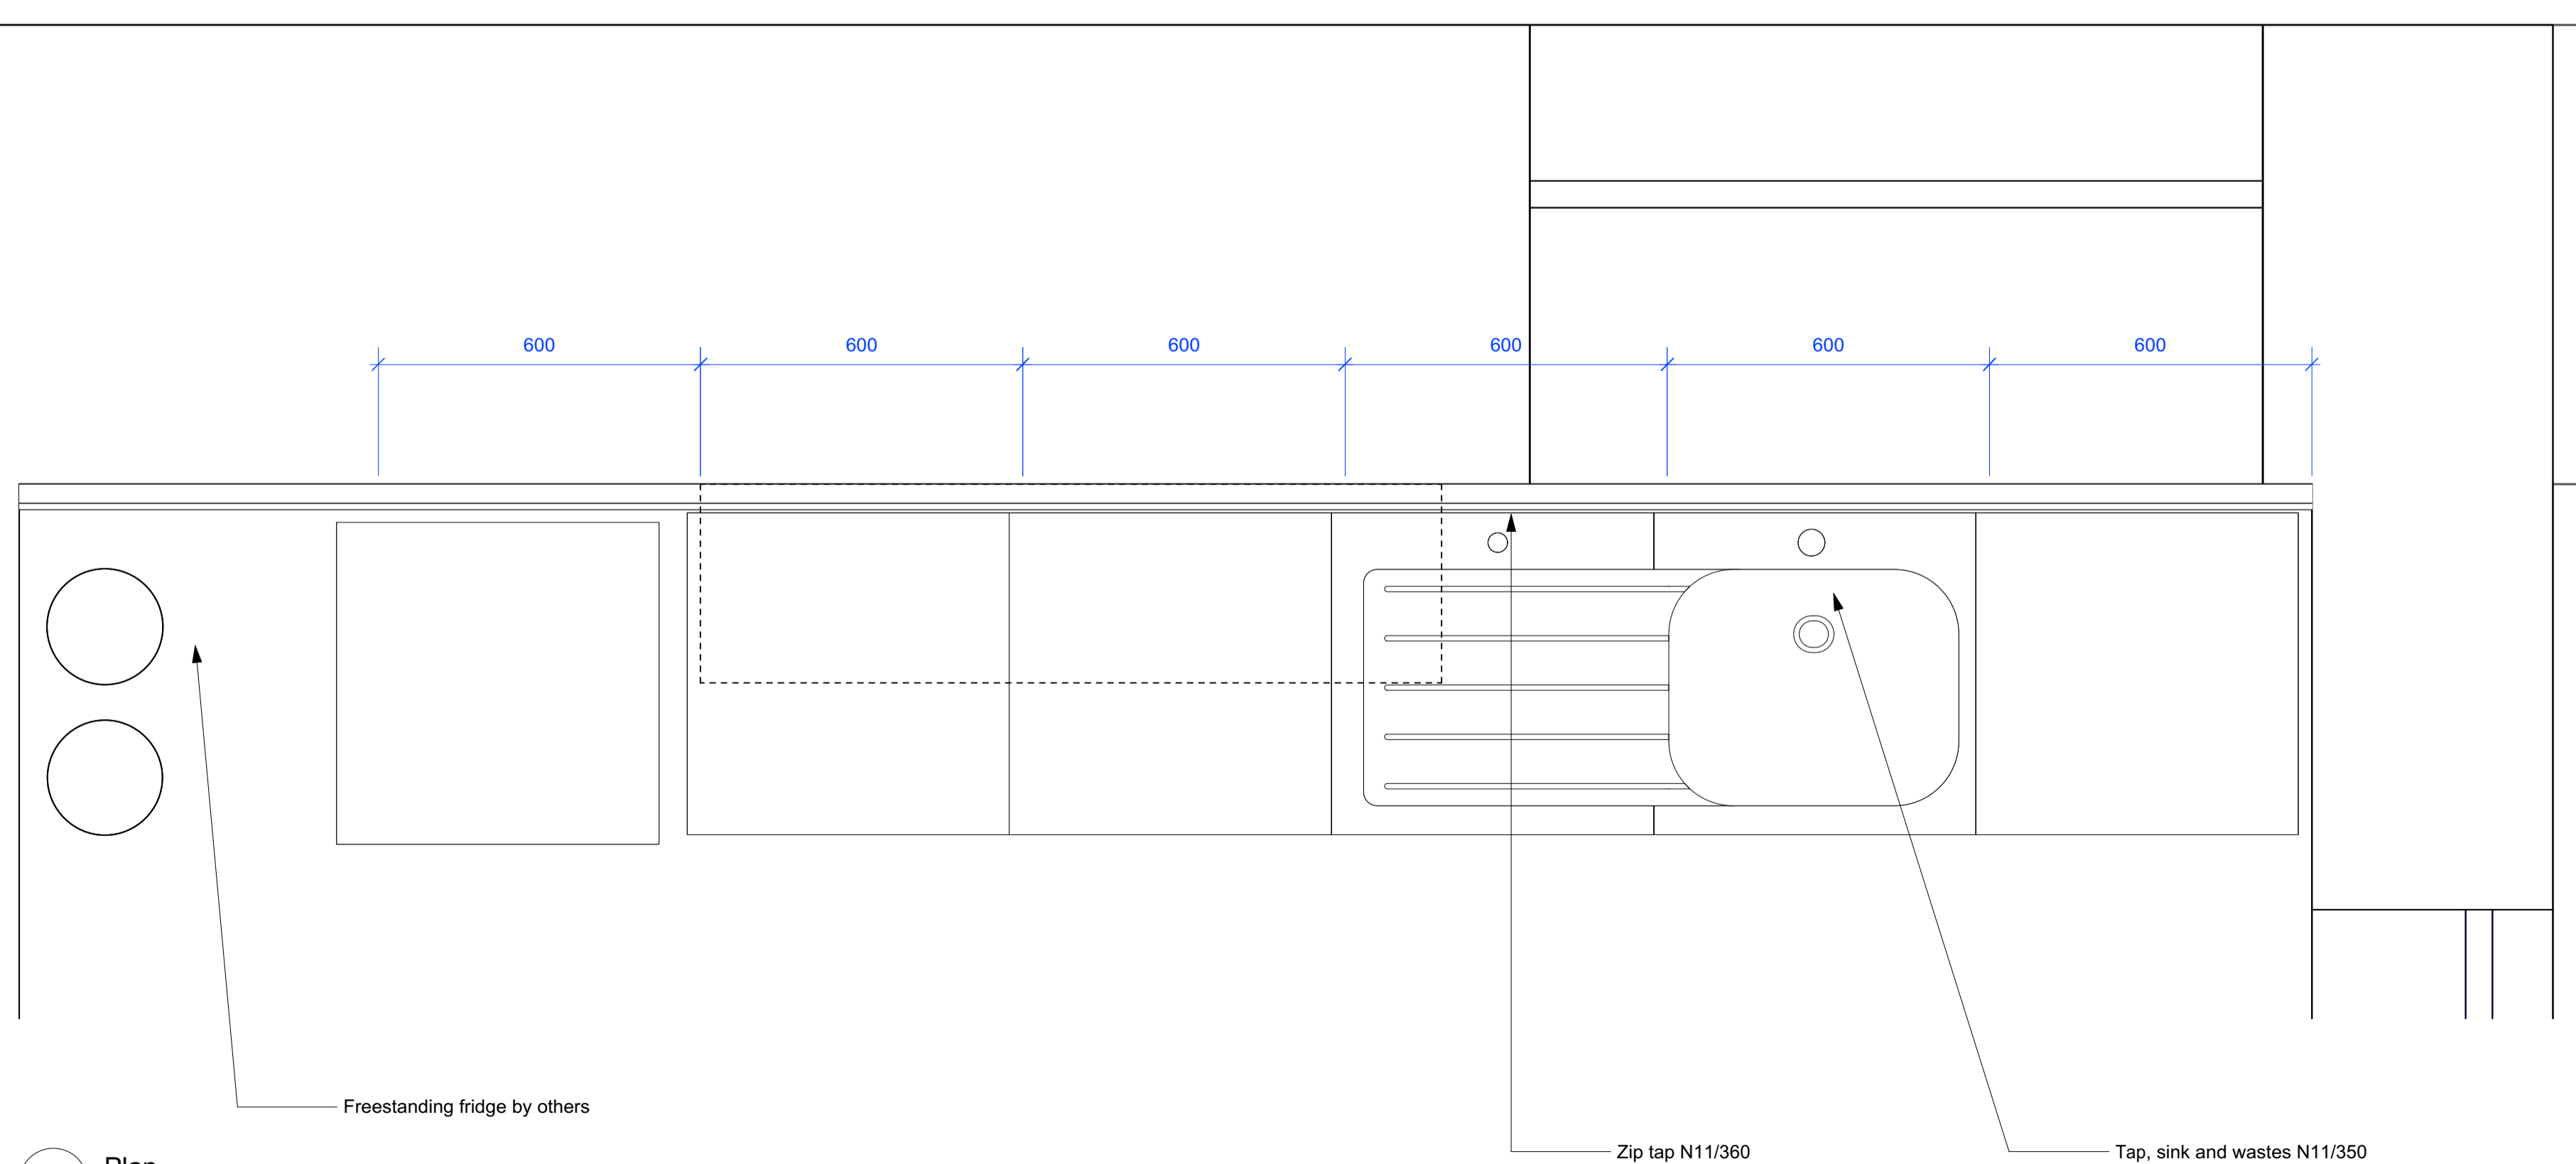

3 Plan  
Scale: 1:10

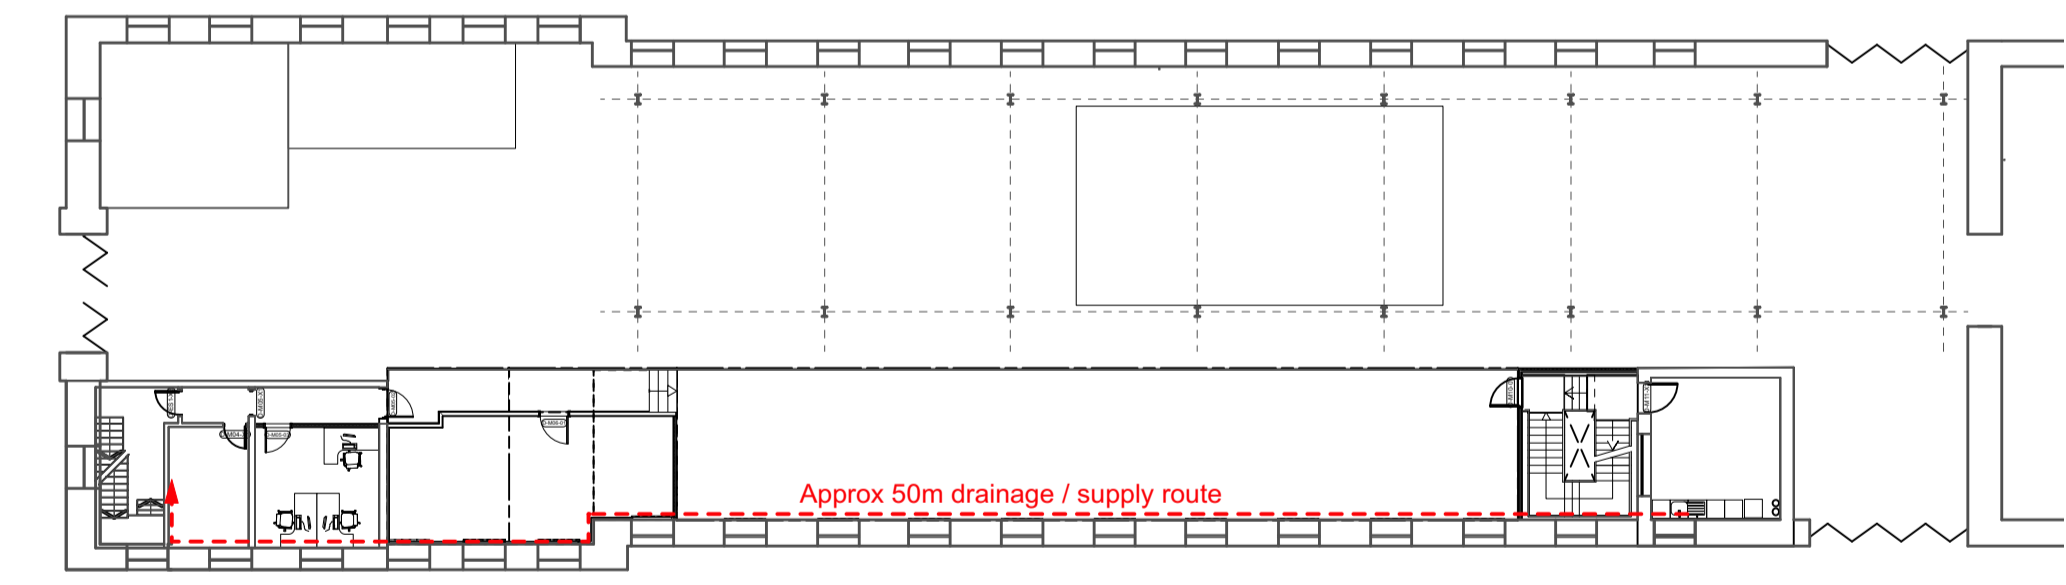

4 First Floor Plan  
Scale: 1:250

P02	20.04.2021	ST	Revised scope issue, renumbered drawing
P01	02.11.2020	ST	Issued for Tender
No.	Date	By	Comments
Revisions			

**TENDER**  
Drawing Status

**NATIONAL MUSEUM OF THE ROYAL NAVY  
HISTORIC SHIPS WORKSHOP**  
**Dannatt, Johnson Architects**  
Unit 1 The Wireworks, 77 Great Suffolk Street, London SE1 0BU  
Telephone (020) 7357 7100 Fax (020) 7357 7200

Drawing Title  
**New Kitchenette**

Drawing Number  
**605b-WD-51-000**

Drawn	Checked	Scale	Date	Revision
ST	DJ	1:100@A1	Aug 2020	P02